




**SIDE ELEVATION**  
SCALE : 1:100

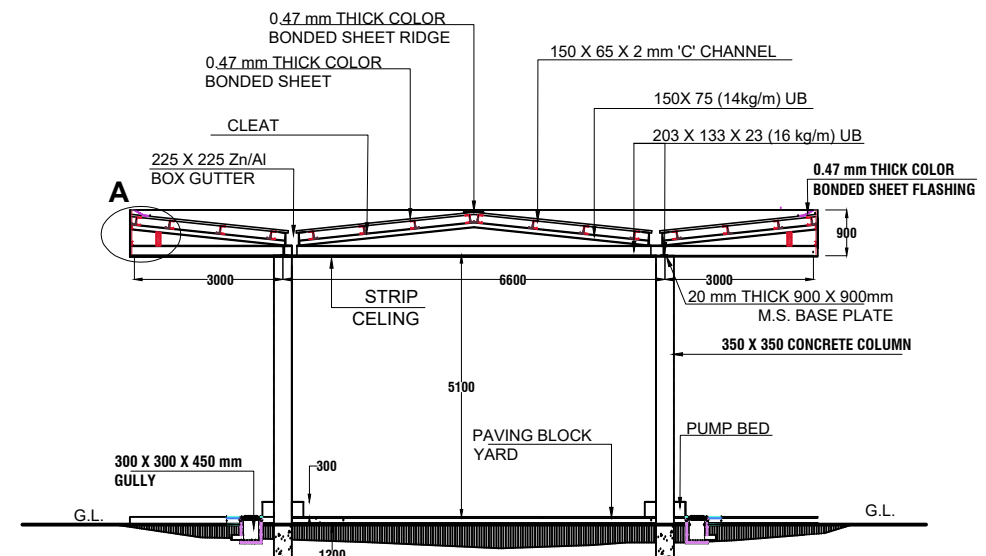


**SECTION AT X-X**  
SCALE : 1:100

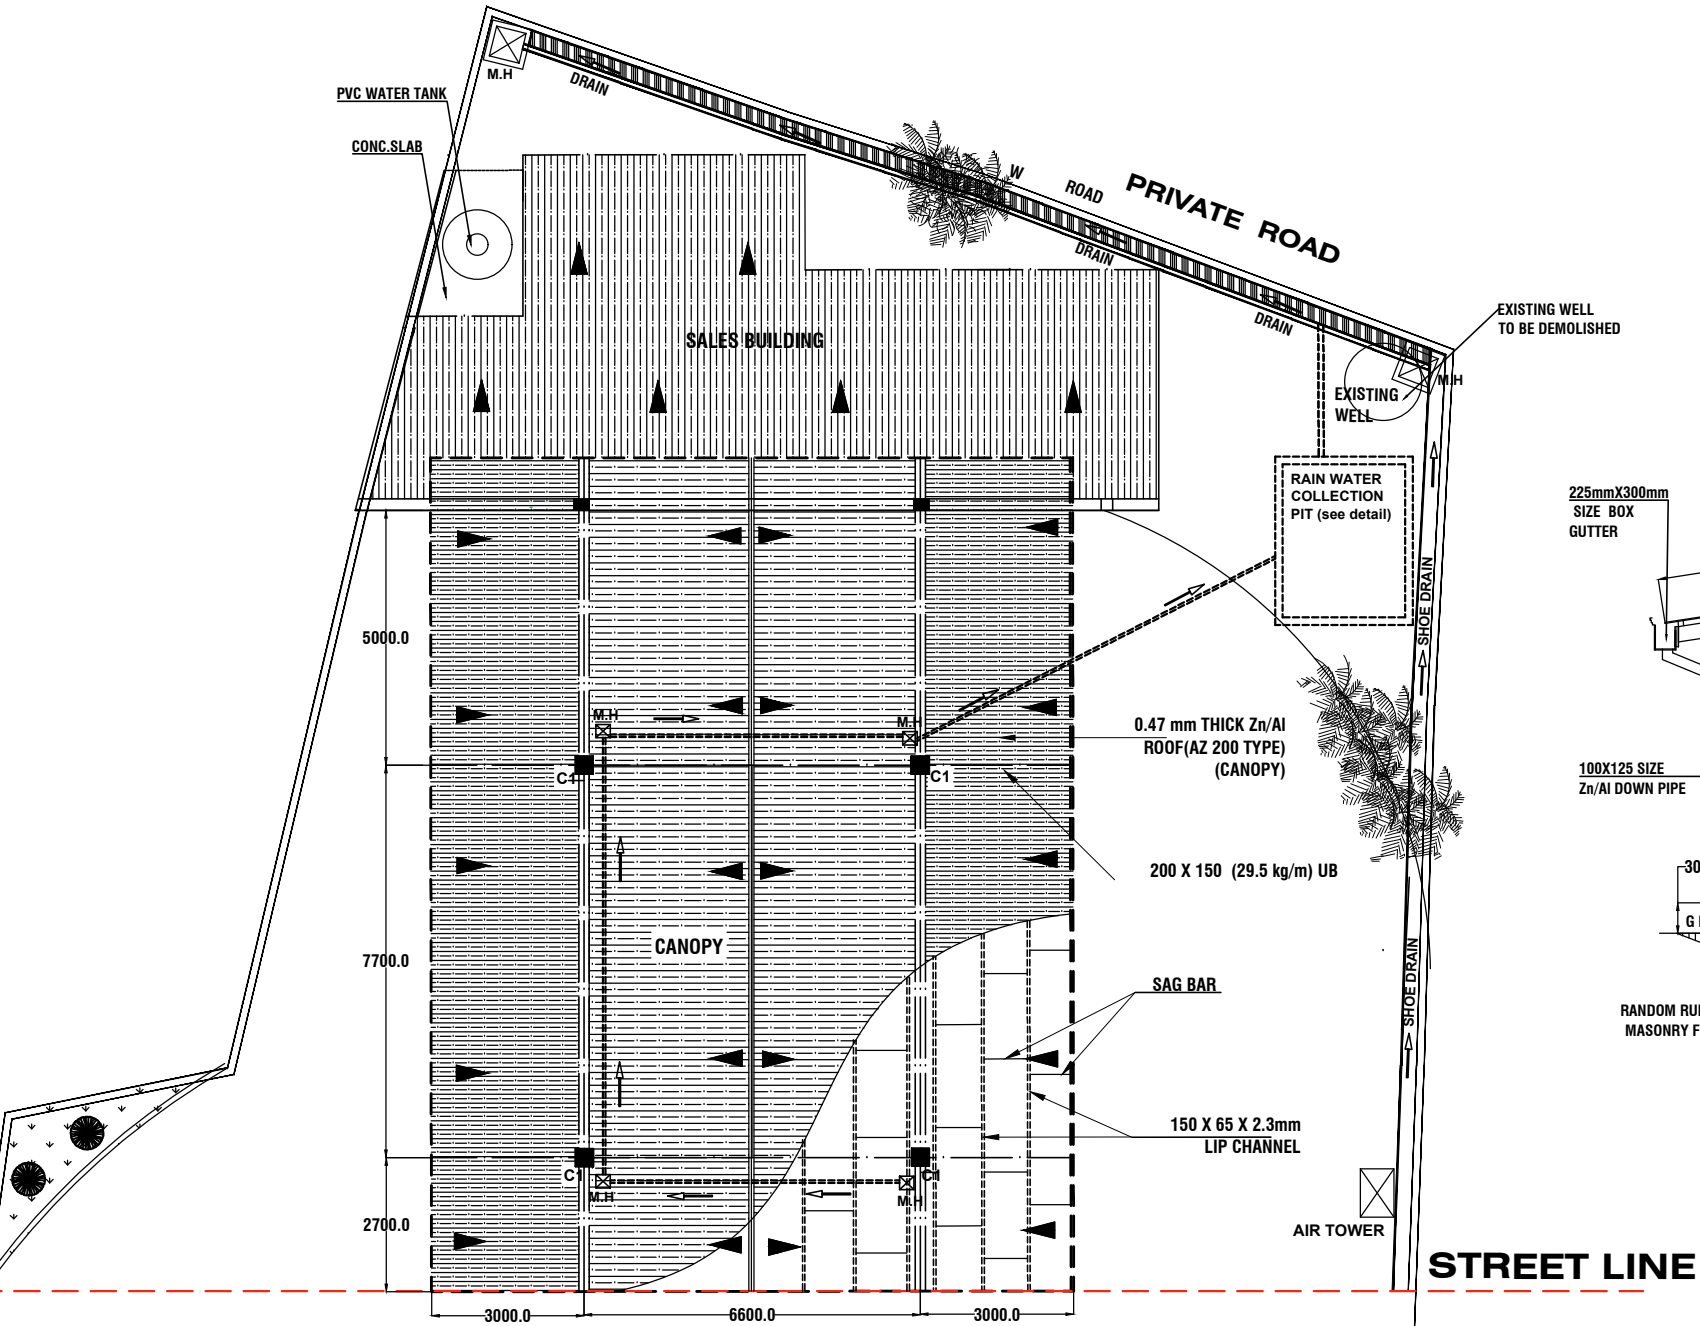


**ROOF PLAN VIEW LAYOUT**  
SCALE:1:100

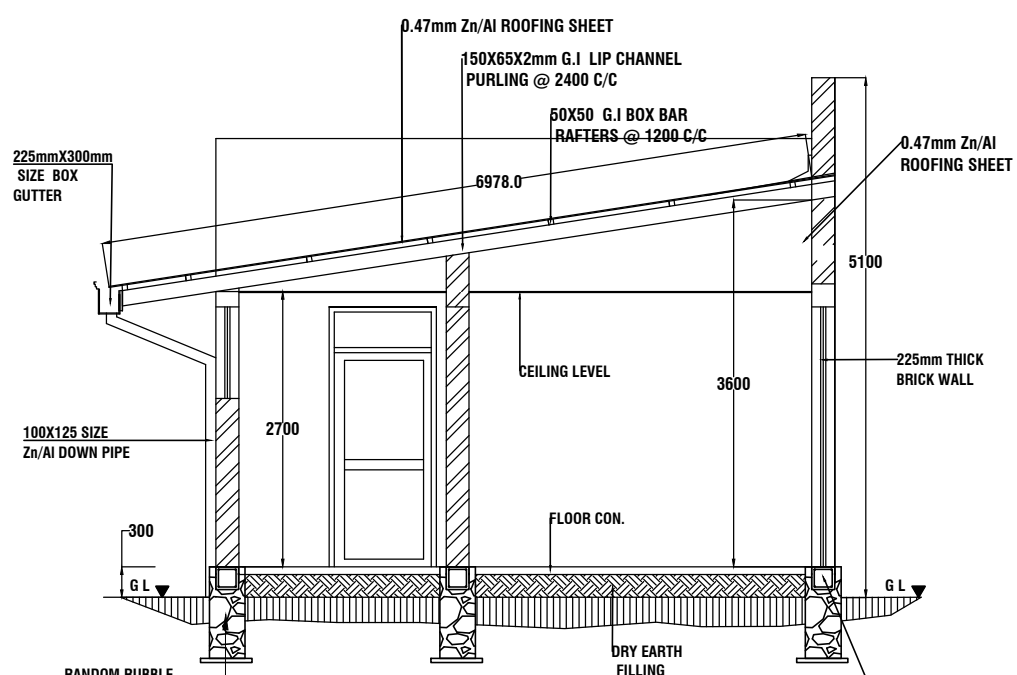


**SECTION AT Y-Y**  
SCALE : 1:50

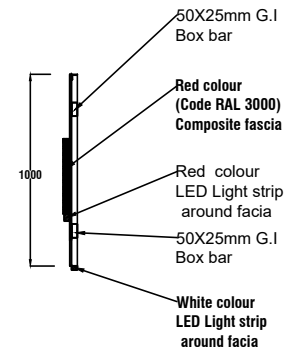

**DETAIL AT -B-**

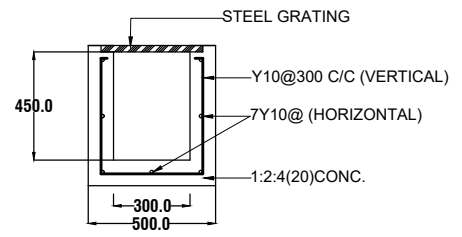

**DETAIL OF RAIN WATER DRAIN**  
SCALE - 1:20

PROJECT :		<b>MODIFICATION OF L.F.S.MARADANA</b>	
TITLE:			
 <b>CEYLON PETROLEUM CORPORATION</b> ENGINEERING DEPARTMENT NO. 609, DR. DANISTER DE SILVA MAWATHA, DEMATAGODA, COLOMBO -09, TP. NO. 5661717, 5661818 FAX 5455408	Designed	R.S	
	Drawn	C.P	PRABATH
	Checked	R.S	
	Approved	G.P.K.Wijekoon Manager (E&P)	
	Scale	AS SHOWN	Date:
Rev.No	Drawing No:	CEYPET/ENG/ 0608	
			Sheet: 03 of 02