


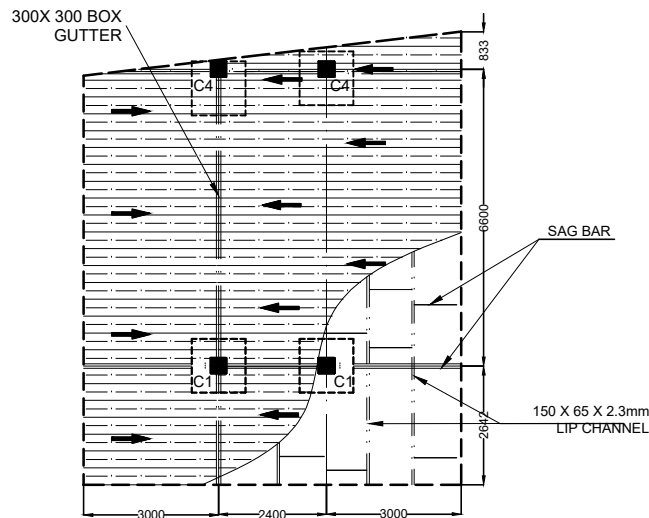
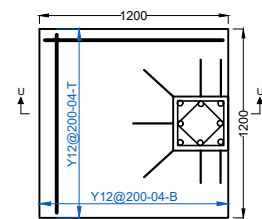


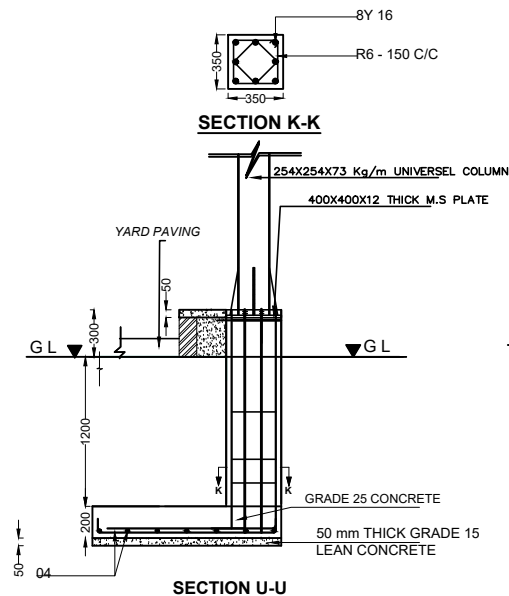



CANOPY ROOF PLAN VIEW
SCALE : 1:100

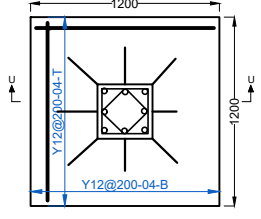



DETAILS AT COLUMN C4
SCALE - 1:25

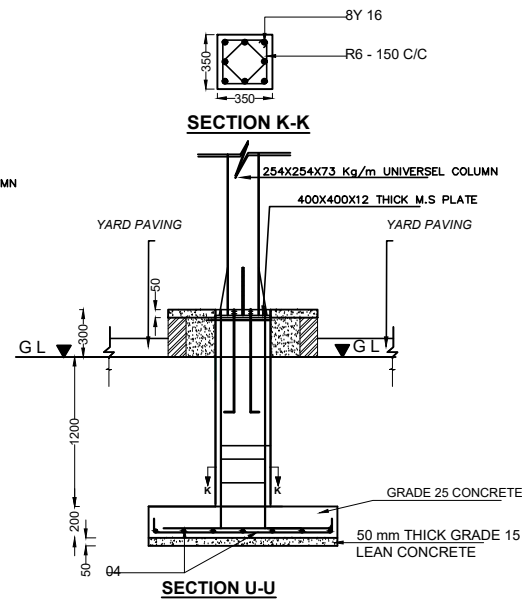


DETAILS AT COLUMN C1
SCALE - 1:25

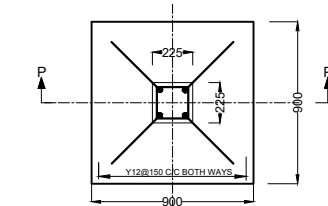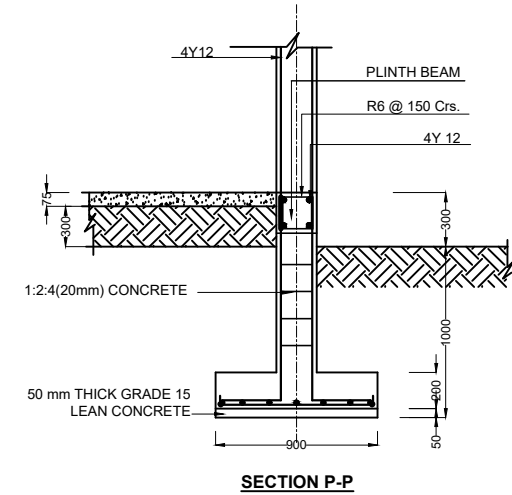


DETAILS AT COLUMN C2

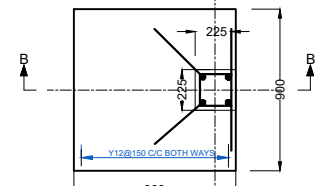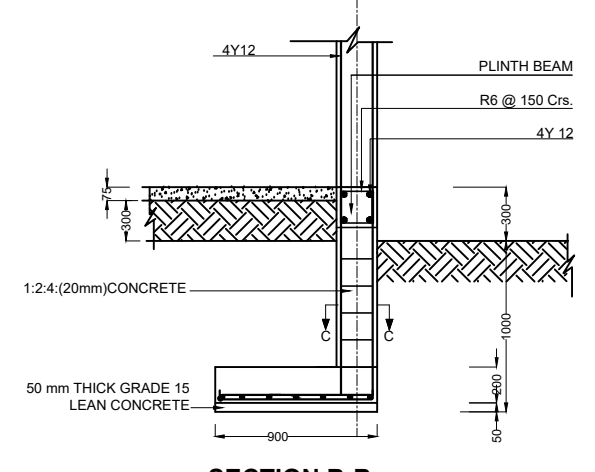


DETAILS AT COLUMN C3

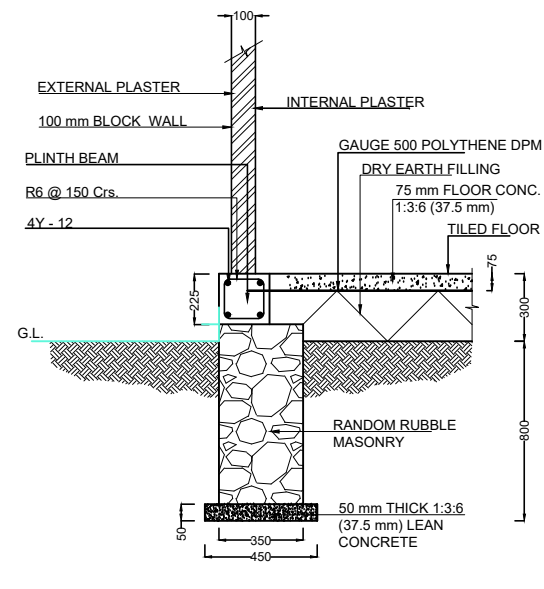


DETAILS OF WALL FOUNDATION
SCALE 1:20

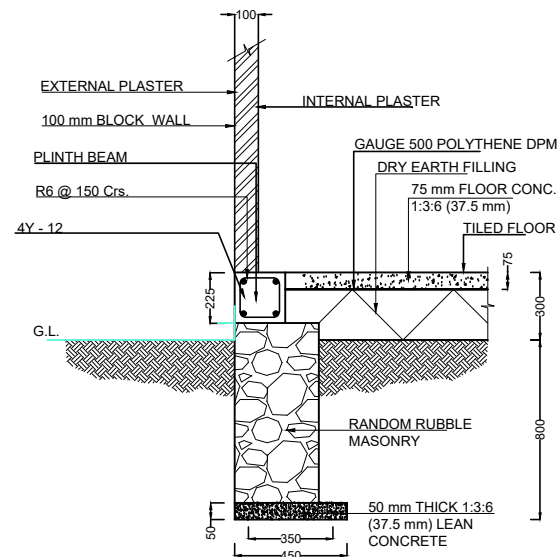

DETAILS OF BLIND WALL FOUNDATION
SCALE 1:20

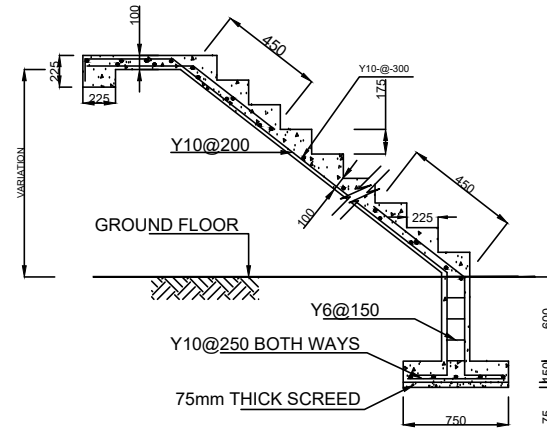

DETAIL OF STAIR CASE

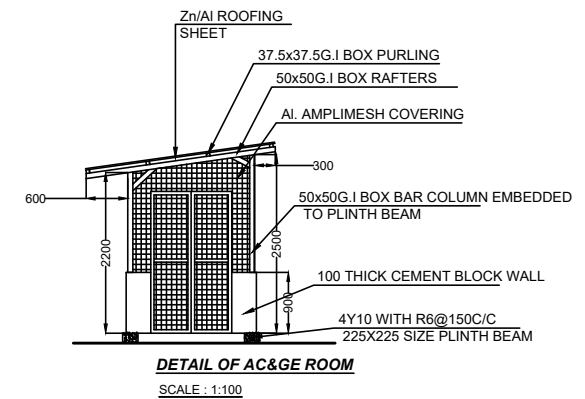

DETAIL OF AC&GE ROOM
SCALE : 1:100

PROJECT :		MODIFICATION OF L.F.S.MIRIGAMA			
TITLE:		DETAILS			
 CEYLON PETROLEUM CORPORATION ENGINEERING DEPARTMENT NO. 609, DR. DANISTER DE SILVA MAWATHA, DEMATAGODA, COLOMBO -09. TP. NO. 5661717, 5661818 FAX 5455408	Designed	R.S			
	Drawn	C.P	PRABATH		
	Checked	R.S			
	Approved	G.P.K.Wijekoon Manager (E&P)			
	Scale	AS SHOWN	Date:	20.03.2024	
Rev.No	Drawing No: CEYPET/ENG/ 0624				Sheet: 03 of 02